



PROJ NO

PROJ TITLE

DATE

REVISION

REVISION


REVISION

REVISION

REVISION

REVISION


REVISION

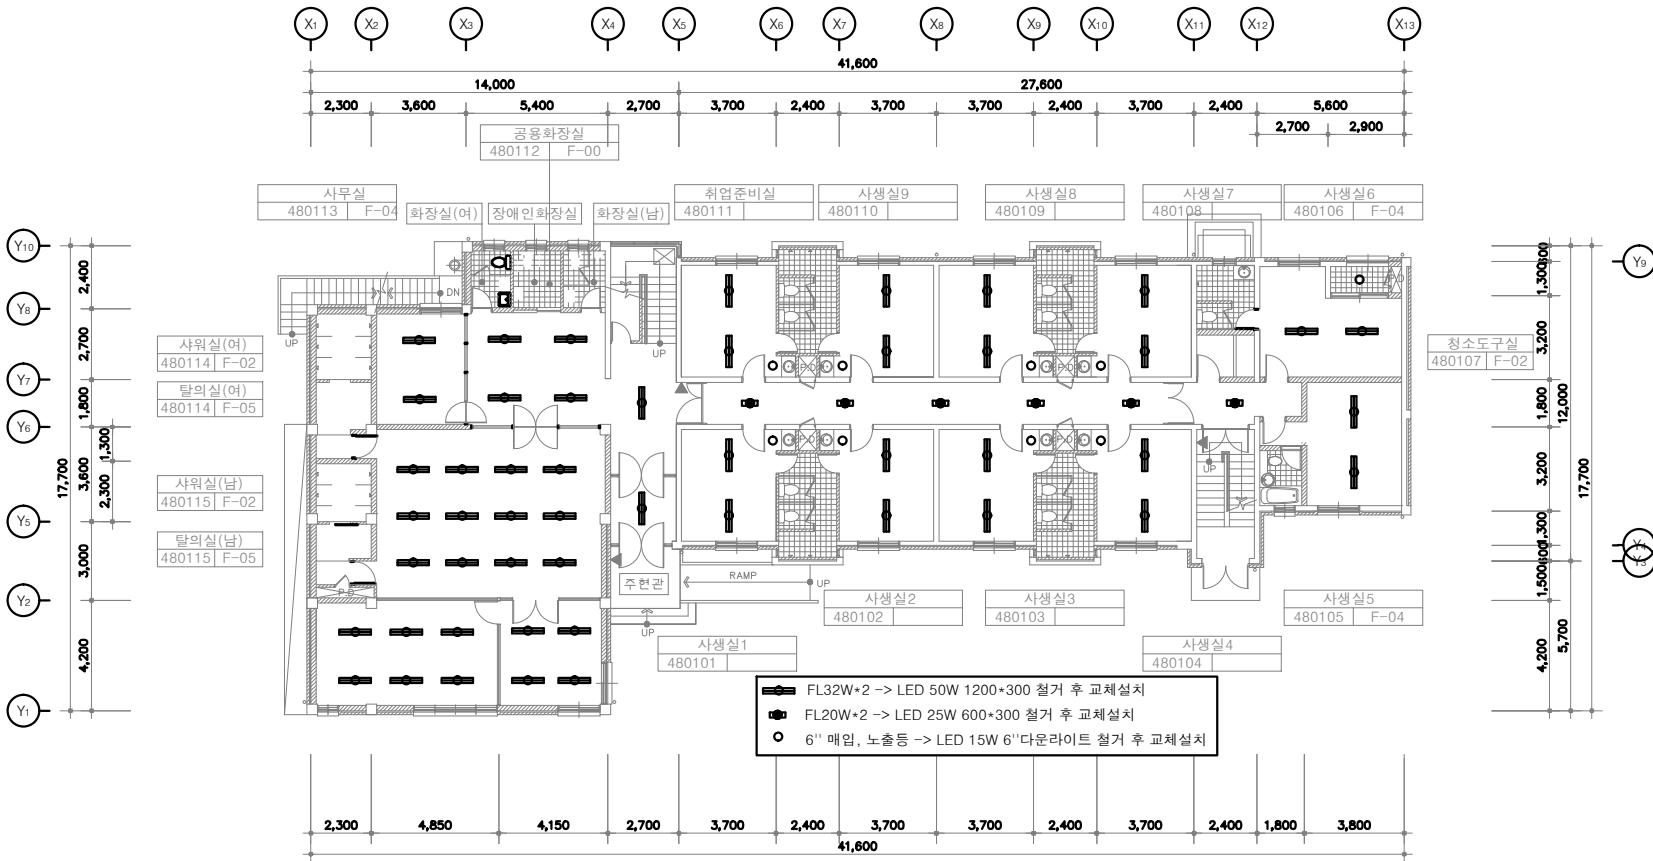

48동 글로벌칼리지 기숙사 1층 전등 배치도




PROJ ID	
PROJ TITLE	
NOTE	
REVISION	
COMPLAINT	
APPROVED BY	
CHECKED BY	
DATE	2006.00.
SCALE	A1 : 1 / 100 A3 : 1 / 200
SHEET NO.	

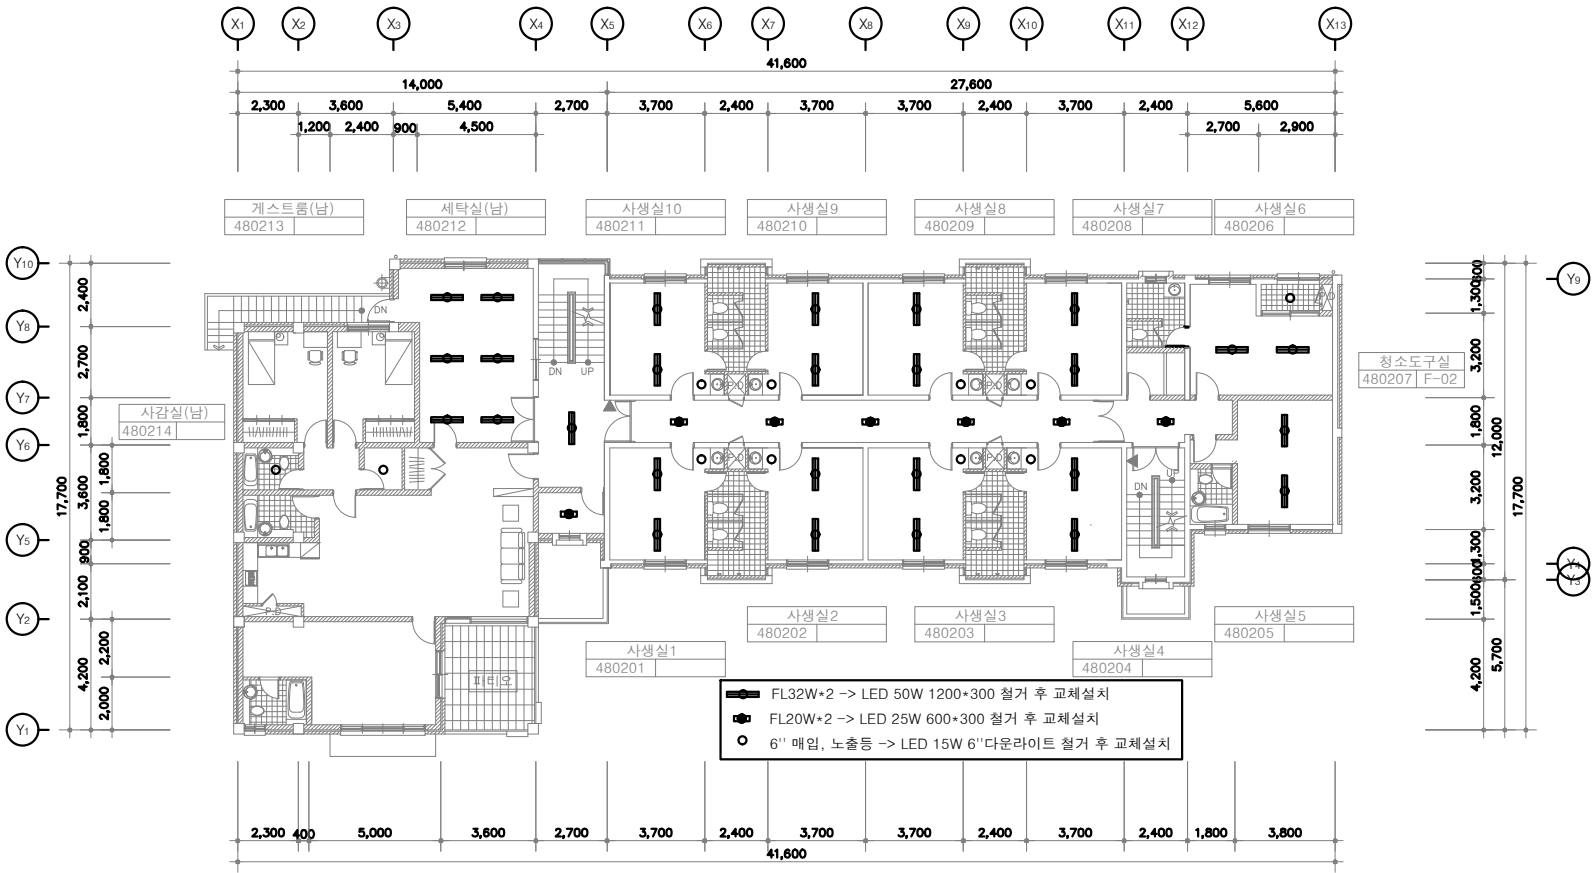

48동 글로벌칼리지 기숙사 2층 전등 배치도




PROJ. NO.	
PROJ. TITLE	
NOTE	
REVISION	
REVISION	
CONTRACTOR	
APPROVED BY	
CHECKED BY	
CHECKED BY	
DESIGN BY	담당자
SCALE	A1 : 1 / 100 A3 : 1 / 200
DATE	2006.00.
DESIGNER	
REVISION	
SHEET NO.	

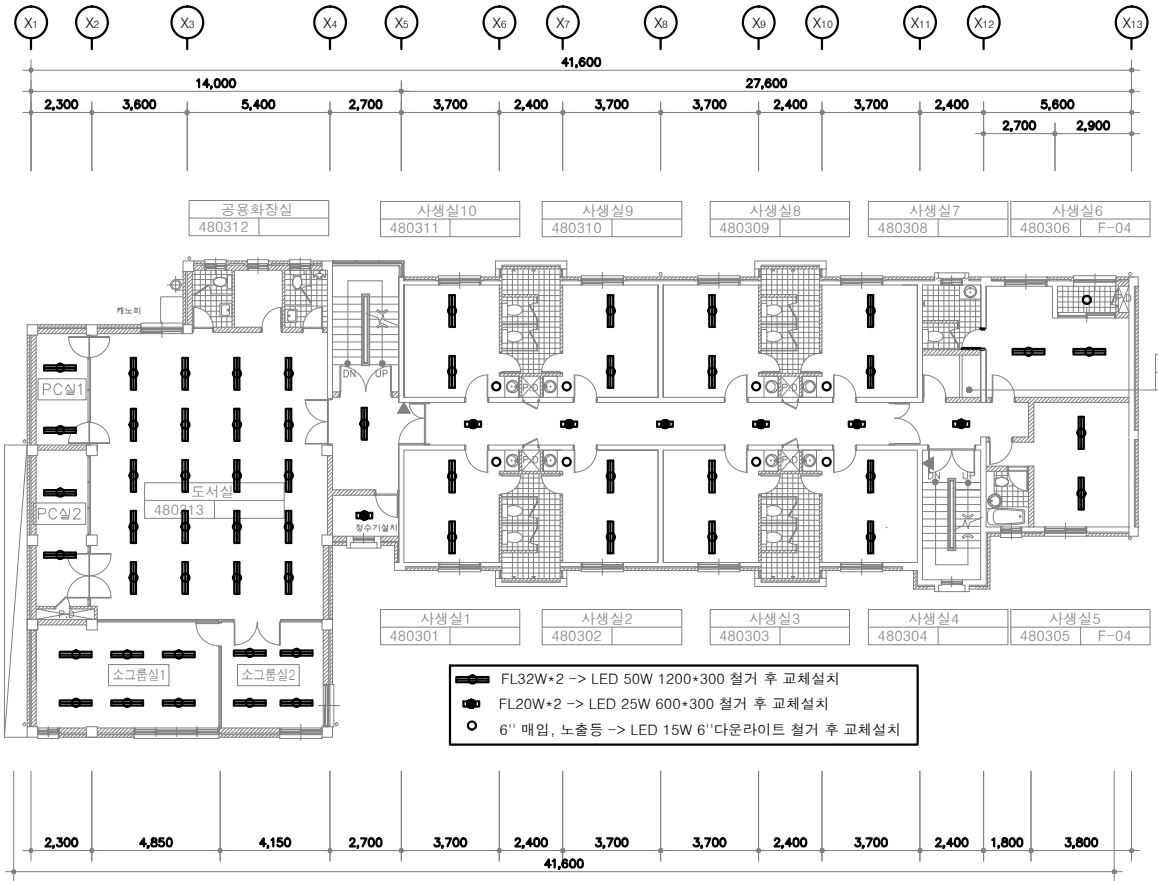

48동 글로벌칼리지 기숙사 3층 전등 배치도



PROJECT NO	
PROJECT TITLE	
DATE	
REVISION	
REVISION	
CONSULTANT	
APPROVED BY	
CHECKED BY	
CHECKED BY	
DRAWN BY	담당자
SCALE	A1 : 1 / 100 A3 : 1 / 200
DATE	2006.00.
PROJECT NO	
SHEET NO.	

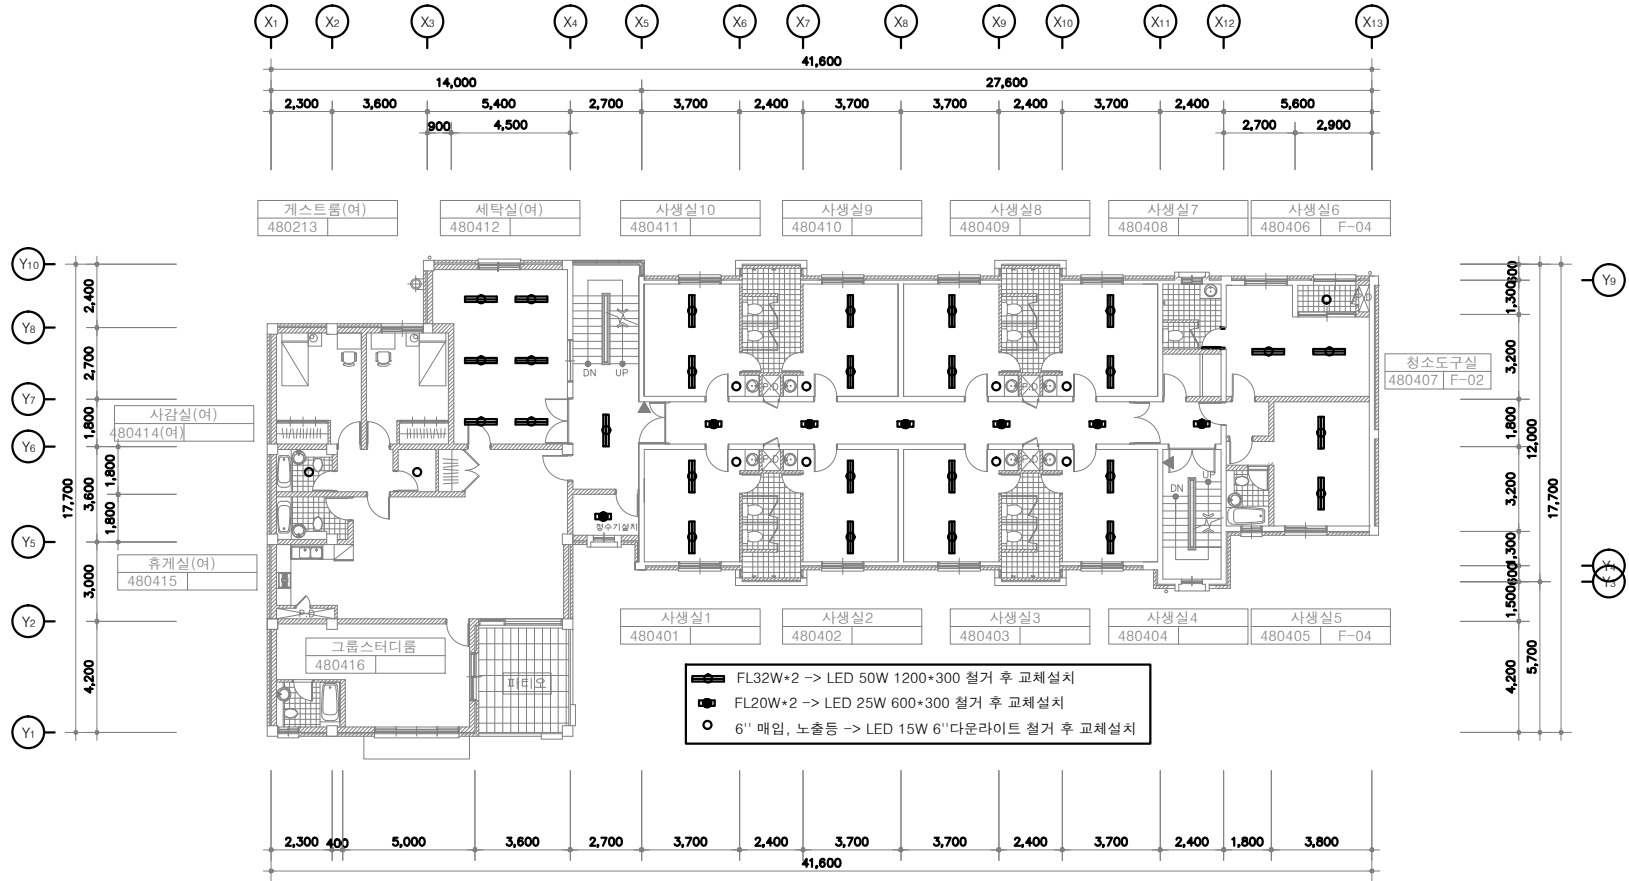

48동 글로벌칼리지 기숙사 4층 전등 배치도